


# ChoiceWash XT<sup>®</sup>




**CHOICEWASH XT<sup>®</sup> FRICTION  
ROLLOVER WITH FS-40D FREESTANDING  
DRYER WITH DOWN CHUTES  
CIRCLE K STORE  
E. FOUNTAIN BLVD & ACADEMY PARK LOOP  
COLORADO SPRINGS, CO 80910**


**FOR BID ONLY**

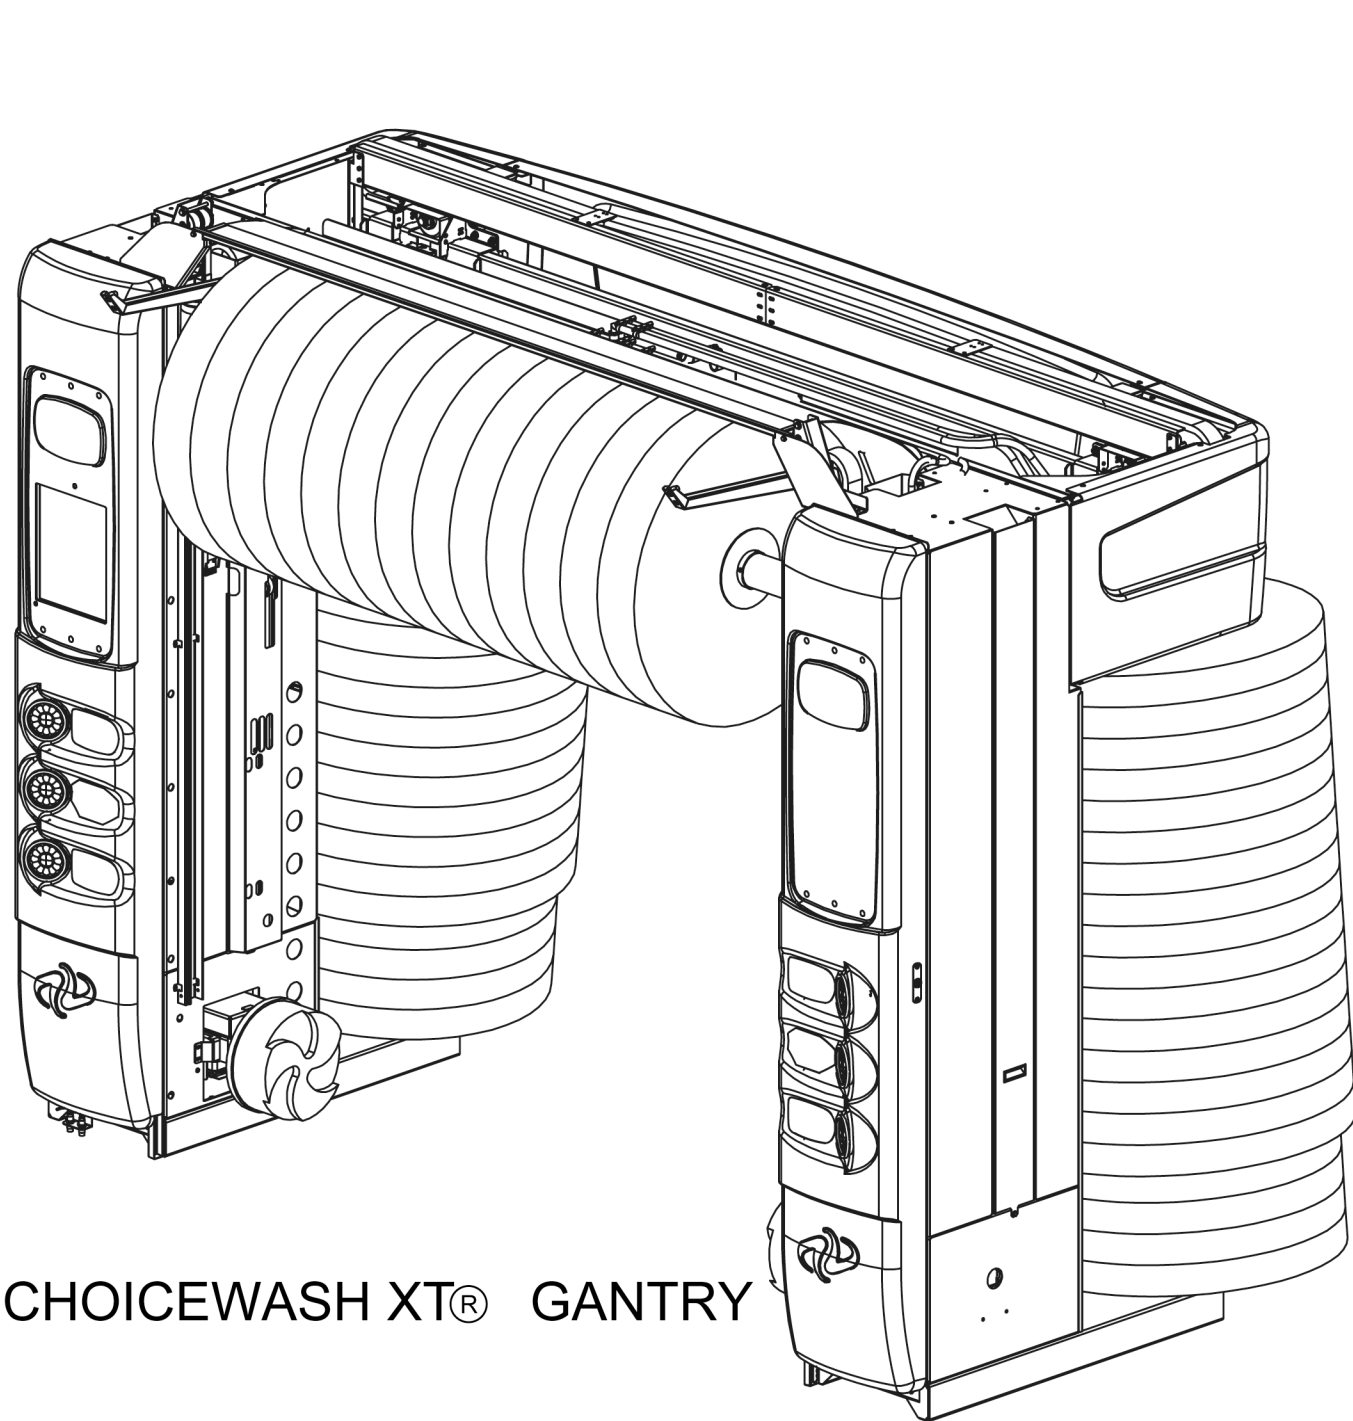

CHOICEWASH XT<sup>®</sup> GANTRY

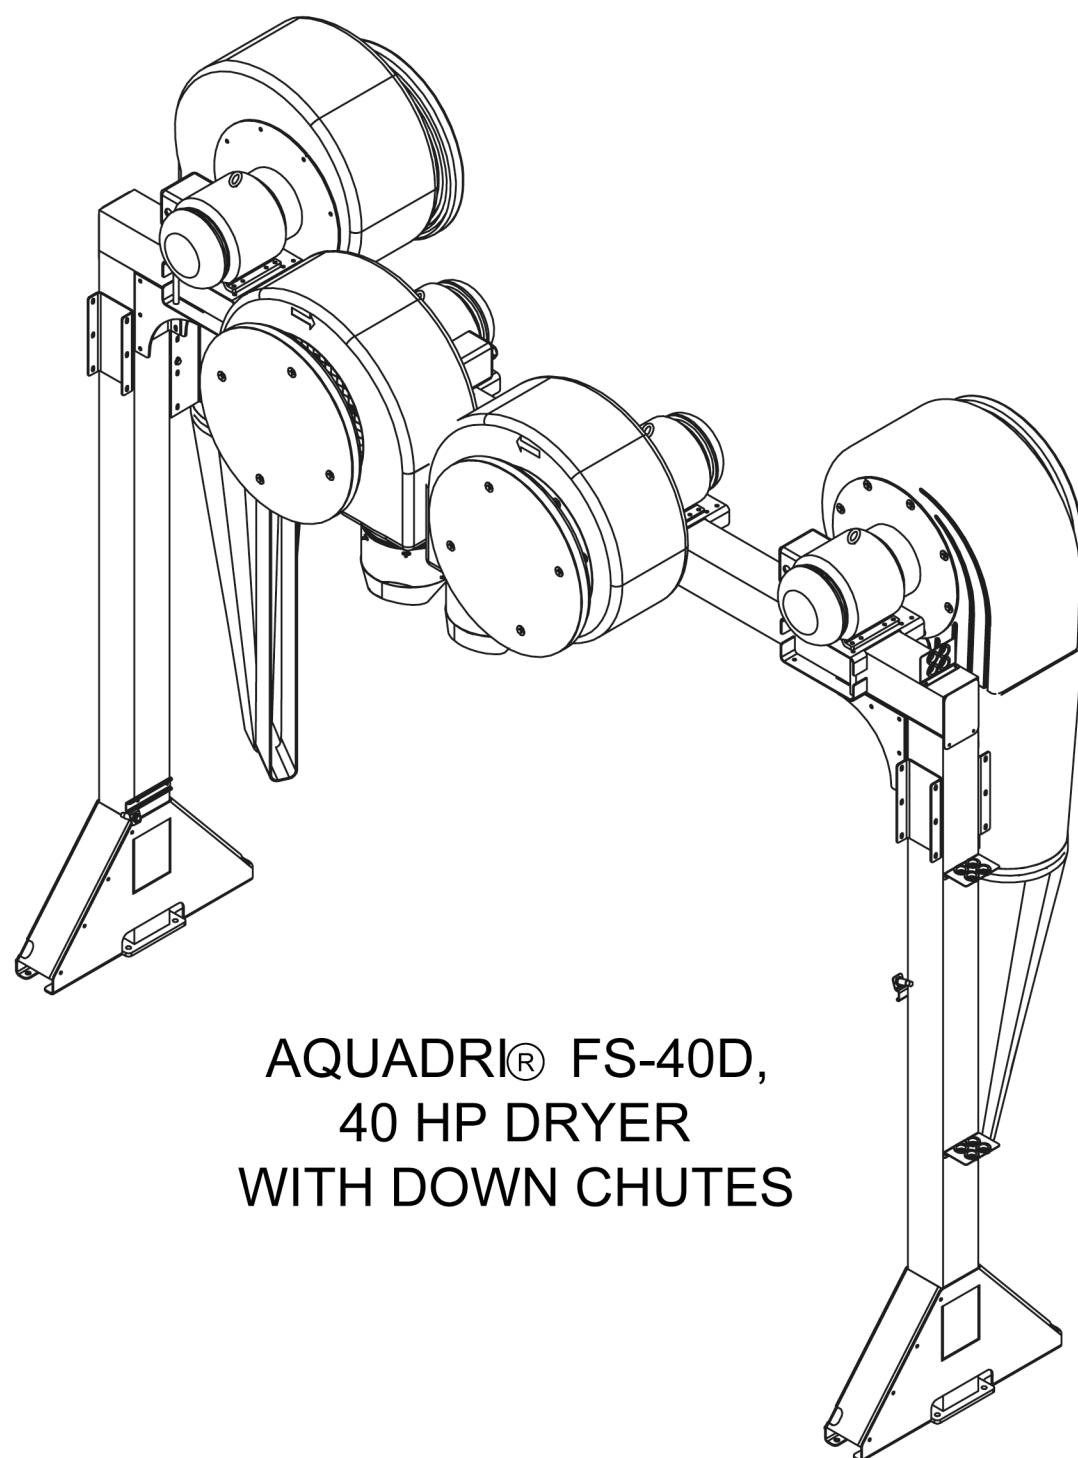

AQUADRI<sup>®</sup> FS-40D,  
40 HP DRYER  
WITH DOWN CHUTES

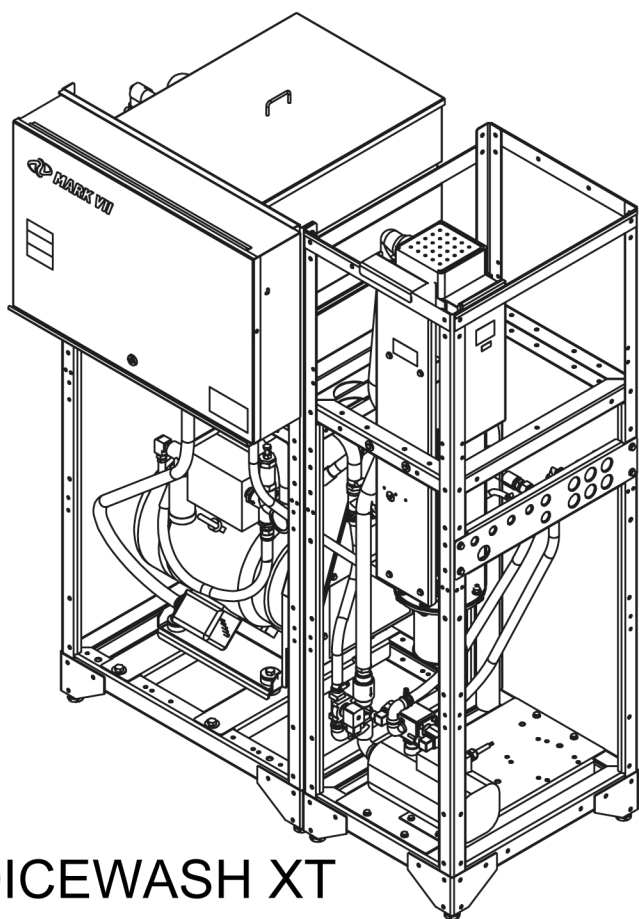

CHOICEWASH XT  
PUMPING PLANT

DRAWING INDEX

SHEET 1	COVER SHEET
SHEET 2	EQUIPMENT SPECIFICATIONS LIST
SHEET 3	EQUIPMENT AND BAY LAYOUT
SHEET 4	EQUIPMENT ROOM AND BAY ELEVATIONS
SHEET 5	PLUMBING AND COMPRESSED AIR DIAGRAM
SHEET 6	EQUIPMENT DETAILS AND DIMENSIONS
SHEET 7	FREESTANDING DRYER DETAILS
SHEET 8	CONTROL WIRING DIAGRAM
SHEET 9	POWER CONTROL DIAGRAM
SHEET 10	FLOOR HEAT-HURON VALLEY SALES
SHEET 11	RECLAIM SYSTEM (EXAMPLE)

THE INFORMATION CONTAINED IN THIS DOCUMENT IS DESIGNED AND INTENDED FOR PRELIMINARY EDUCATION AND PLANNING PURPOSES ONLY. THESE DRAWINGS IN NO WAY REPRESENT FINAL ARCHITECTURAL OR STRUCTURAL DRAWINGS OR PLANS. MARK VII EQUIPMENT IS NOT RESPONSIBLE FOR THE ACTUAL RESULTS OF EFFORTS IMPLEMENTED DUE TO THE INFORMATION CONTAINED IN THIS DOCUMENT.

DRAWING HISTORY			
REVISION:	DESCRIPTION OF CHANGE:	DATE:	DRAWN BY:
01	INITIAL DRAWING RELEASE	8/1/14	JCH
REVISION:	DESCRIPTION OF CHANGE:	DATE:	DRAWN BY:
REVISION:	DESCRIPTION OF CHANGE:	DATE:	DRAWN BY:

PROPOSED DRAWINGS FOR:

CIRCLE K STORE, FOUNTAIN BLVD COLORADO SPRINGS, CHOICEWASH XT w/FS-40D DRYER

SHEET DESCRIPTION:  
**COVER SHEET**

REVISION:  
01

REF. DRAWING NUMBER:  
BL-1408-01-01

DRAWN BY:  
J HAGAN

DATE:  
8/1/14

SCALE:  
NTS

SHEET:  
1 OF 11

SIZE:  
D

